

client
LABTECH
Buck Street Market

project
Retail Units 1.09 / 1.10 & 1.12 / 1.13
Fit-out Details

content				
SDJ	1/20 @ A1	JR.656	4	D(3)20
drawn	1/40 @ A3			
Nov 19				
date	scale	job no.	stage	drawing no.


unit 6 pool bank business park high street tarvin chester ch3 8jh
t 01829 749010 enquiries@johnsonrobson.co.uk

date:	revision:
17/11/19	○ First issue




Lighting colours:
Units 1.09 & 1.10 - RAL 1018
Units 1.12 & 1.13 - RAL 5003

LIGHTING LEGEND	
⊙	Ceiling mounted drop spot - Orilights ref: ORL1009-SF-120 Colour: as schedule
⊕	Ceiling mounted pendant light - ref: TBC Colour: as schedule
≡	Slim Cylinder Track Light - Orilights ref: TBC Colour: as schedule

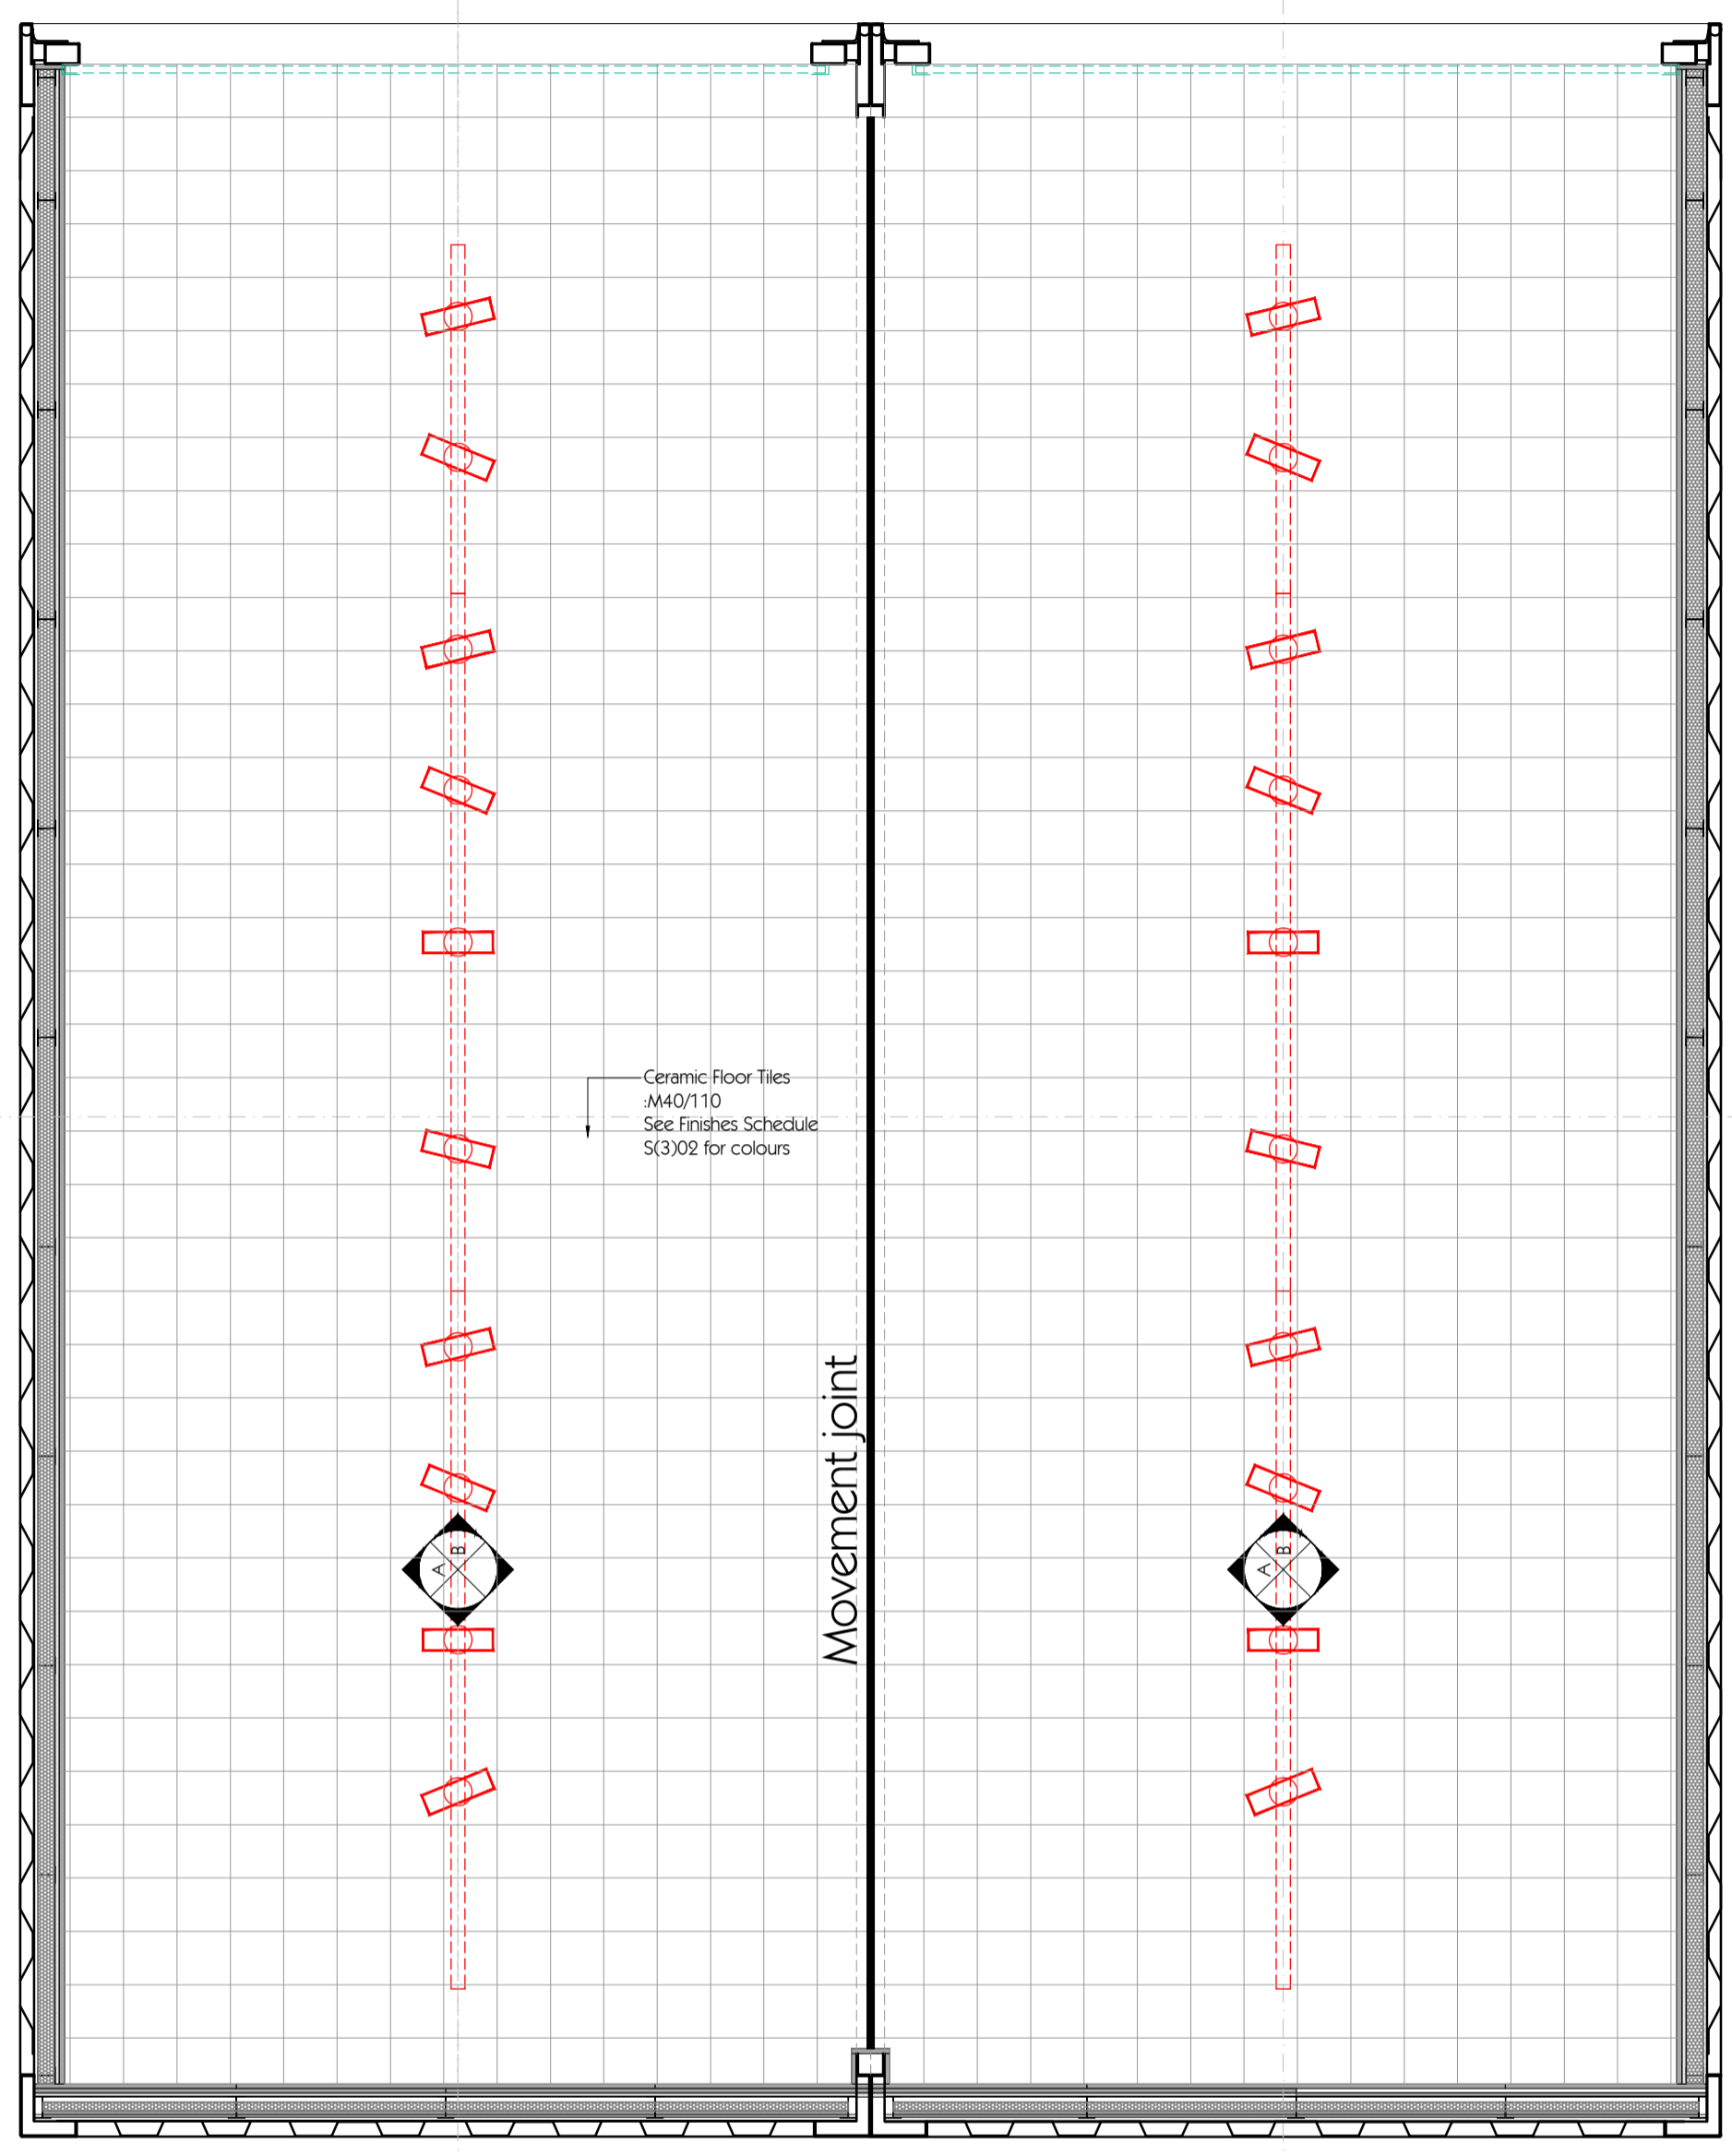

1. Layout Plan
scale 1/20 @ A1

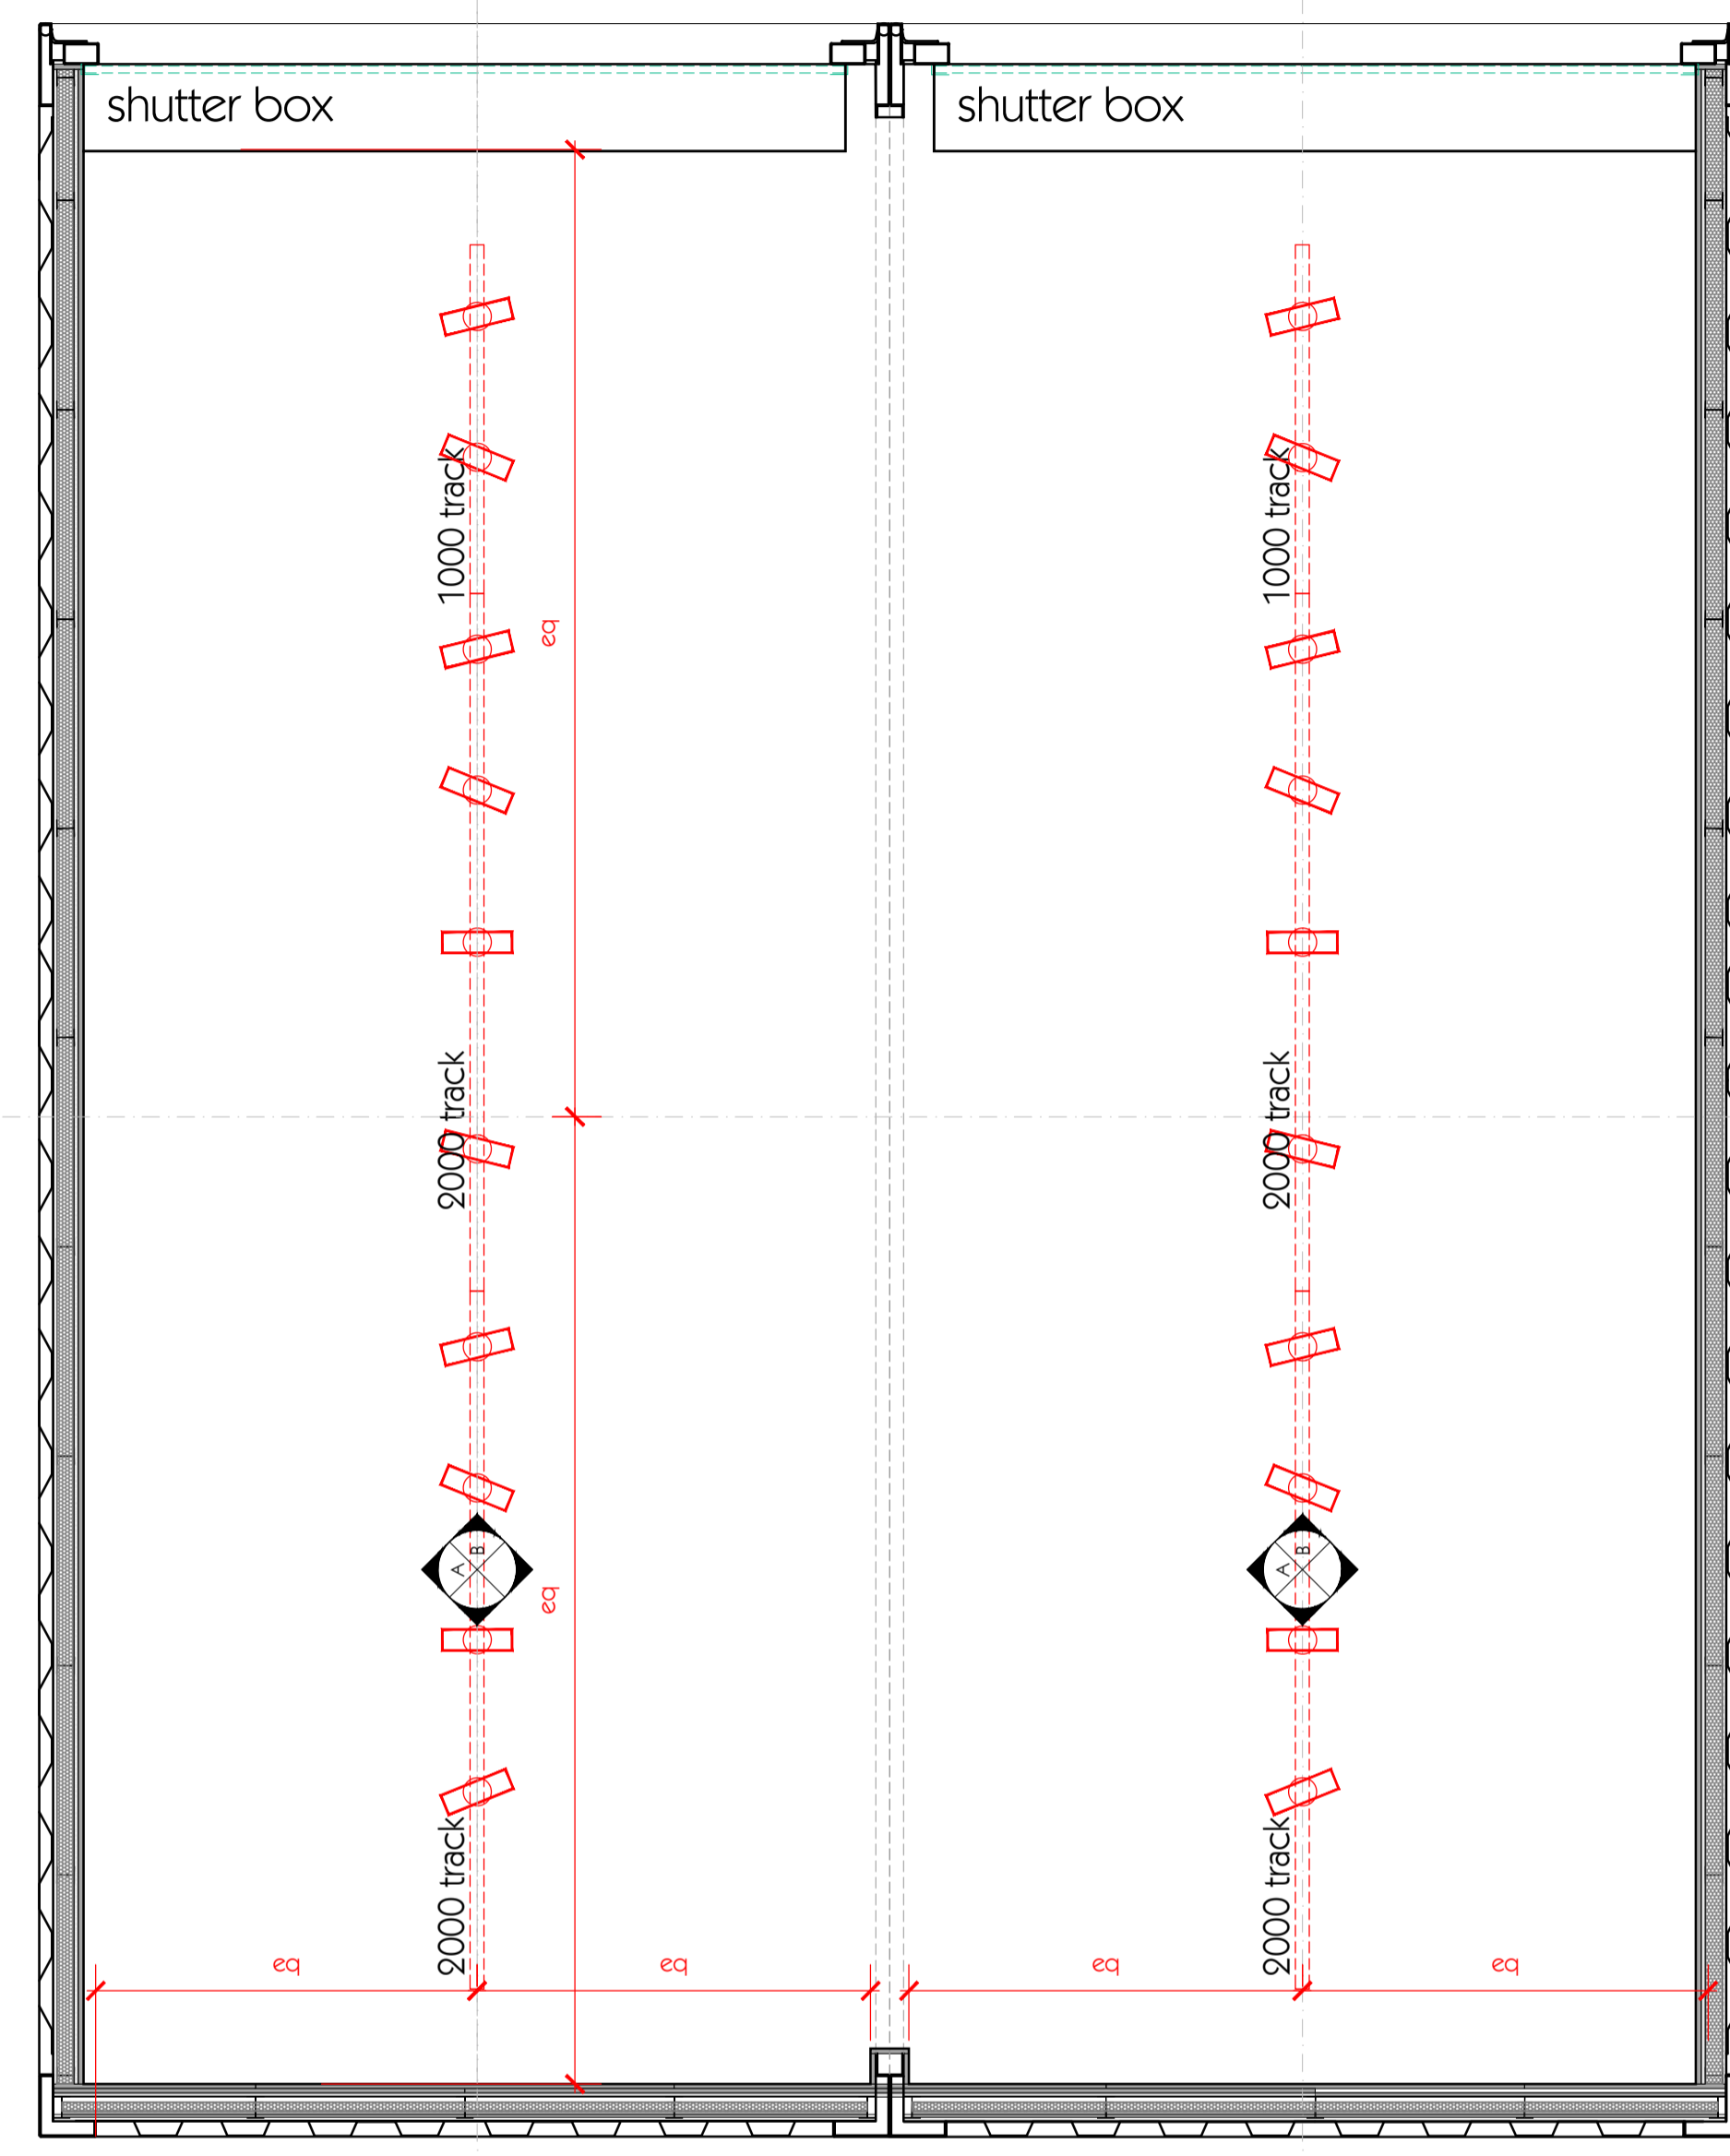

2. Reflected Ceiling Plan
scale 1/20 @ A1